




 









Drawings must NOT be scaled. Contractor must check and verify all dimensions, specifications and drawings on site and report any discrepancies to the architect prior to proceeding with any of the work.



LEGEND


-  TV PANEL
-  TOUCH SCREEN
-  VOLUME
-  CEILING SPEAKERS
-  WALL SPEAKERS
-  AUTOMATED LIGHTS
-  LIGHT CONTROL KEYPADS
-  TELEPHONE
-  DATA
-  TV OUTLET
-  RECESSED POT LIGHT
-  PENDANT LIGHT
-  WALL MOUNTED LIGHT

| REF. | DATE | DESCRIPTION |
|-----------------------|------|-------------|
| REVISIONS / ISSUANCE: | | |

CLIENT:

ADDRESS: LOT 13 FAIRFIELD ESTATES
 CITY: TOWNSHIP OF KING, ONTARIO
 DRAWING TITLE:
 GROUND FLOOR PLAN

DRAWN: O.E.S.
 DATE: NOV. 09 SCALE: 1/4"=1'-0"
 JOB NUMBER: SHEET NUMBER:
 DSI-2

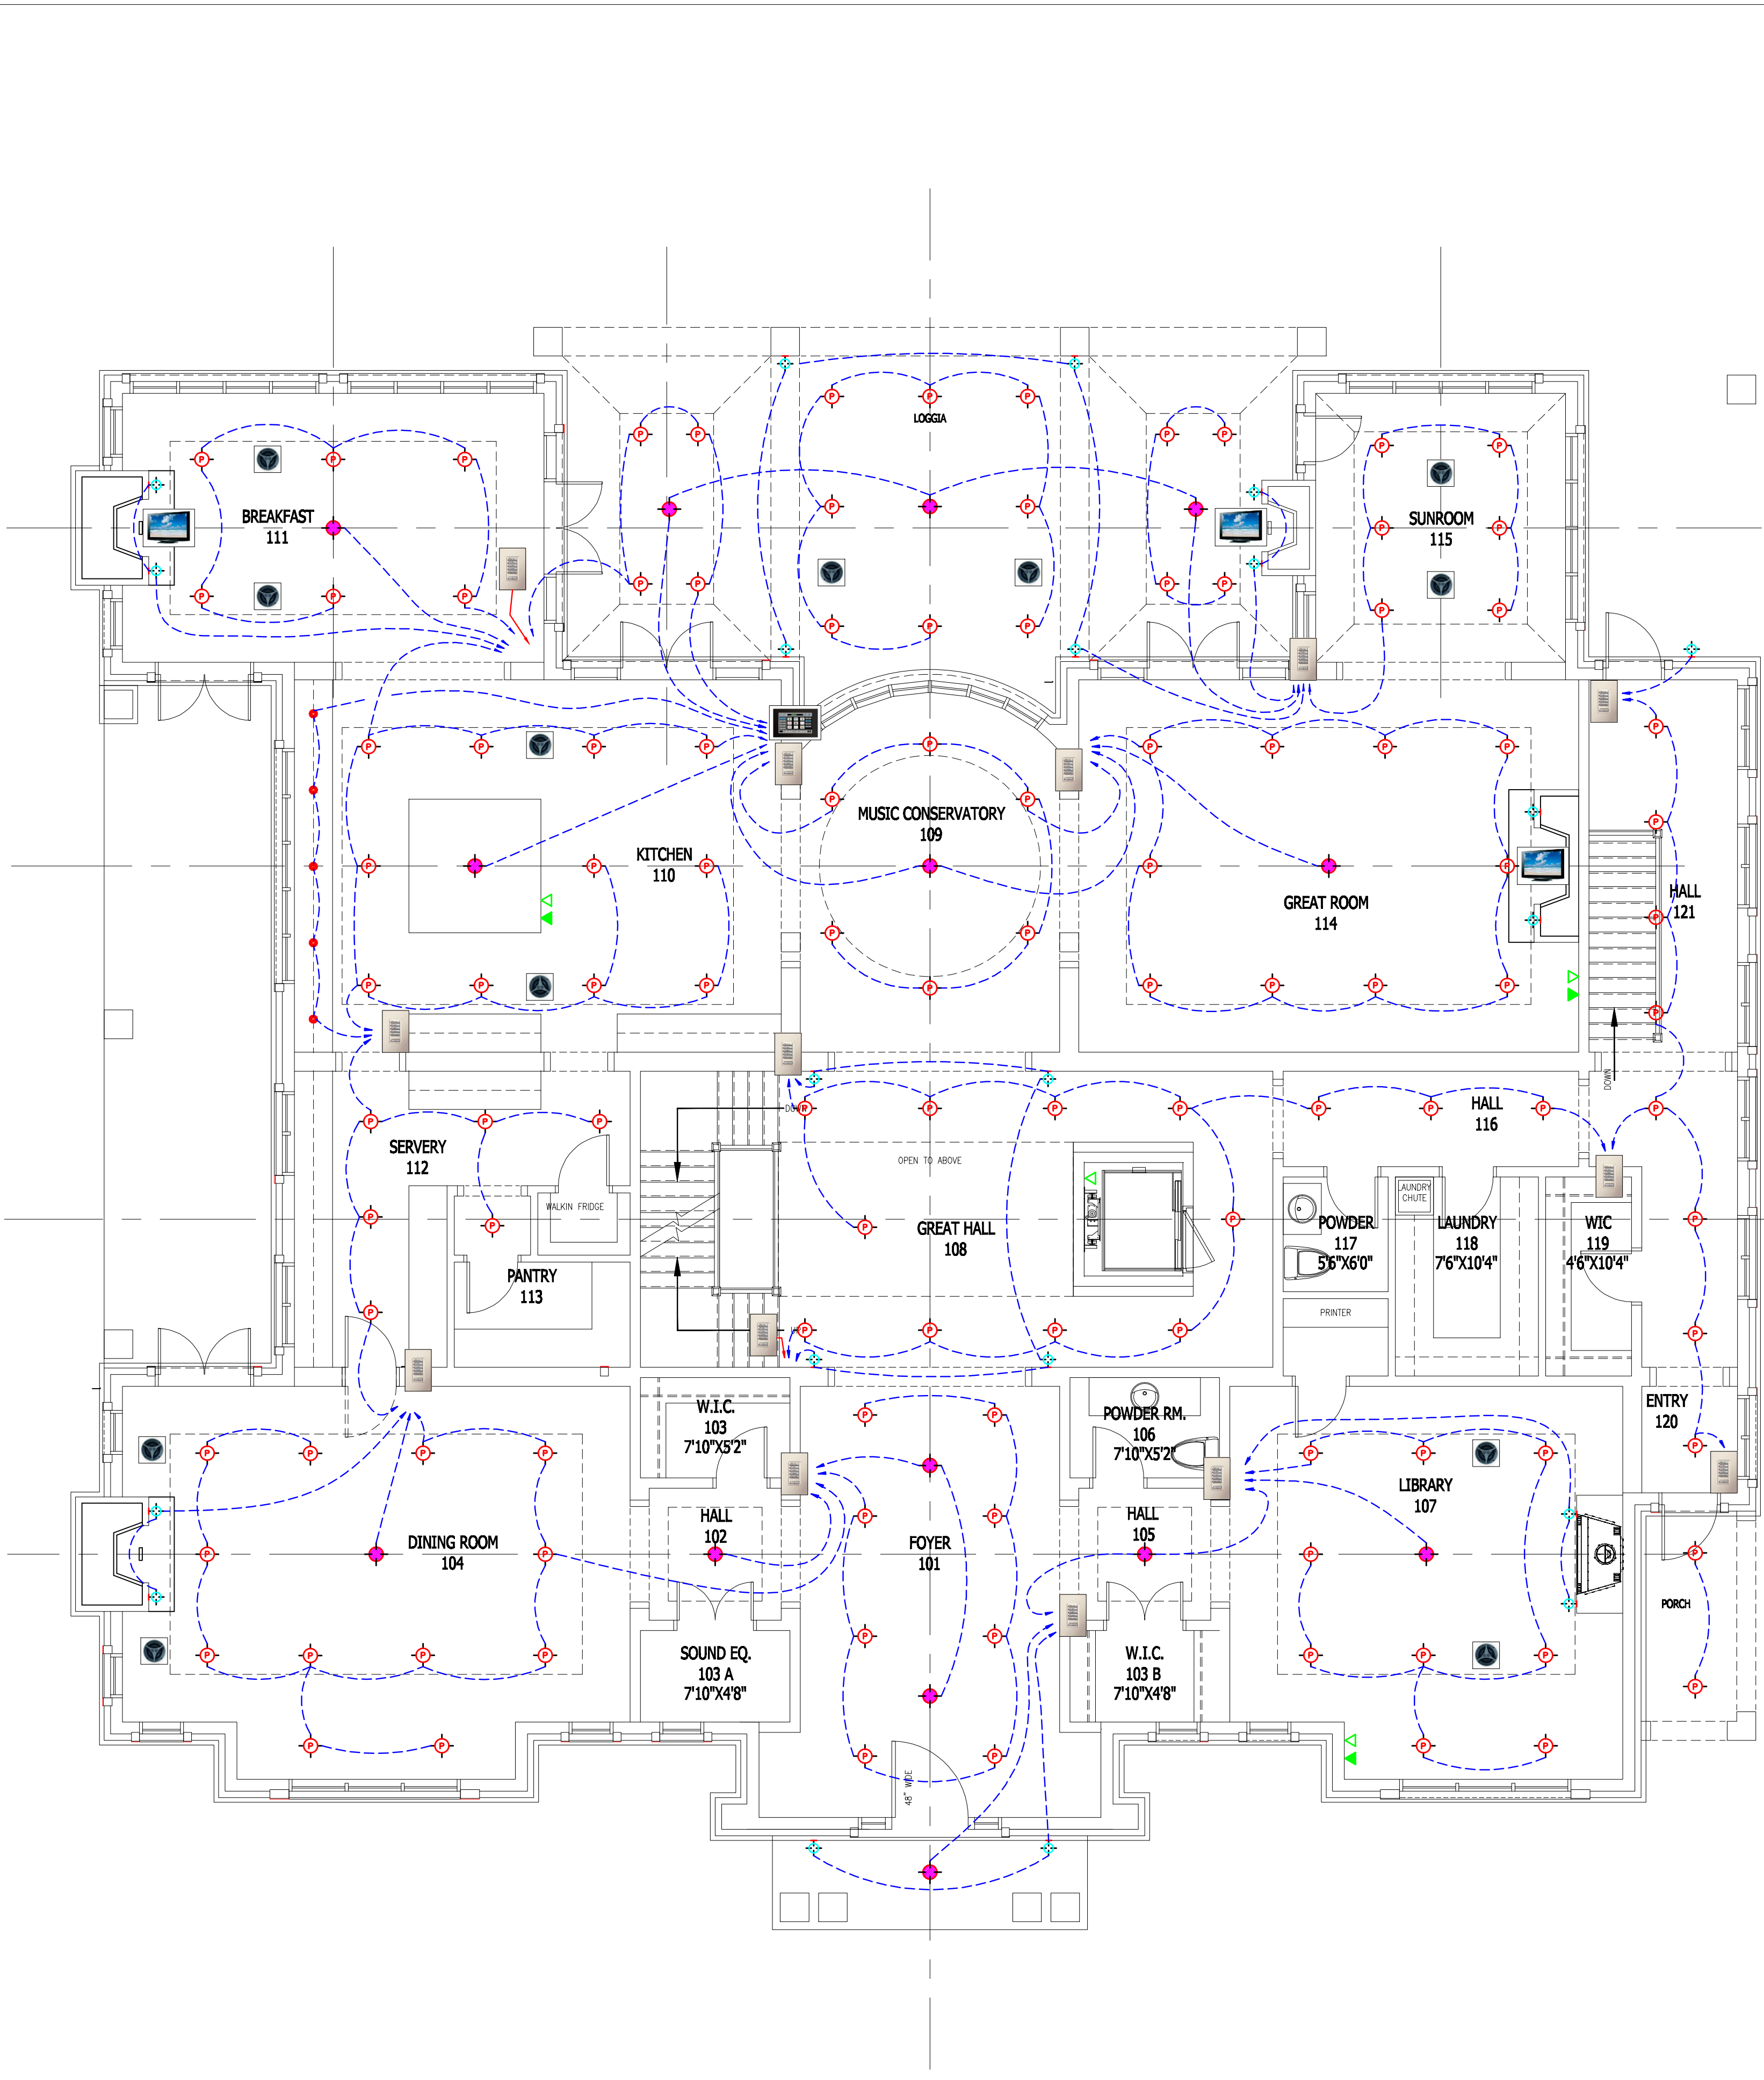

GROUND LIGHTING FLOOR PLAN
 SCALE: 1/4"=1'-0"